

Updated Social Development Plan

Project Number: 41924-014
October 2016

Nam Ngiep 1 Hydropower Project (Lao People's Democratic Republic)

Annexes A to B (2 of 2)


Prepared by Nam Ngiep 1 Power Company Limited for the Asian Development Bank

This report is a document of the borrower. The views expressed herein do not necessarily represent those of ADB's Board of Directors, Management, or staff, and may be preliminary in nature. Your attention is directed to the "Terms of Use" section of this website.

In preparing any country program or strategy, financing any project, or by making any designation of or reference to a particular territory or geographic area in this document, the Asian Development Bank does not intend to make any judgments as to the legal or other status of any territory or area.

Ordinate point for building:

01/.	x=2059603.79
	y=349754.58
02/.	x=2059610.02
	y=349765.08
03/.	x=2059609.13
	y=349751.42
04/.	x=2059615.35
	y=349761.91
05/.	x=2059614.12
	y=349754.30
06/.	x=2059617.51
	y=349760.02
07/.	x=2059617.69
	y=349752.18
08/.	x=2059621.08
	y=349757.90
09/.	x=2059617.53
	y=349780.17
10/.	x=2059620.42
	y=349785.05
11/.	x=2059624.99
	y=349775.74
12/.	x=2059627.89
	y=349780.62

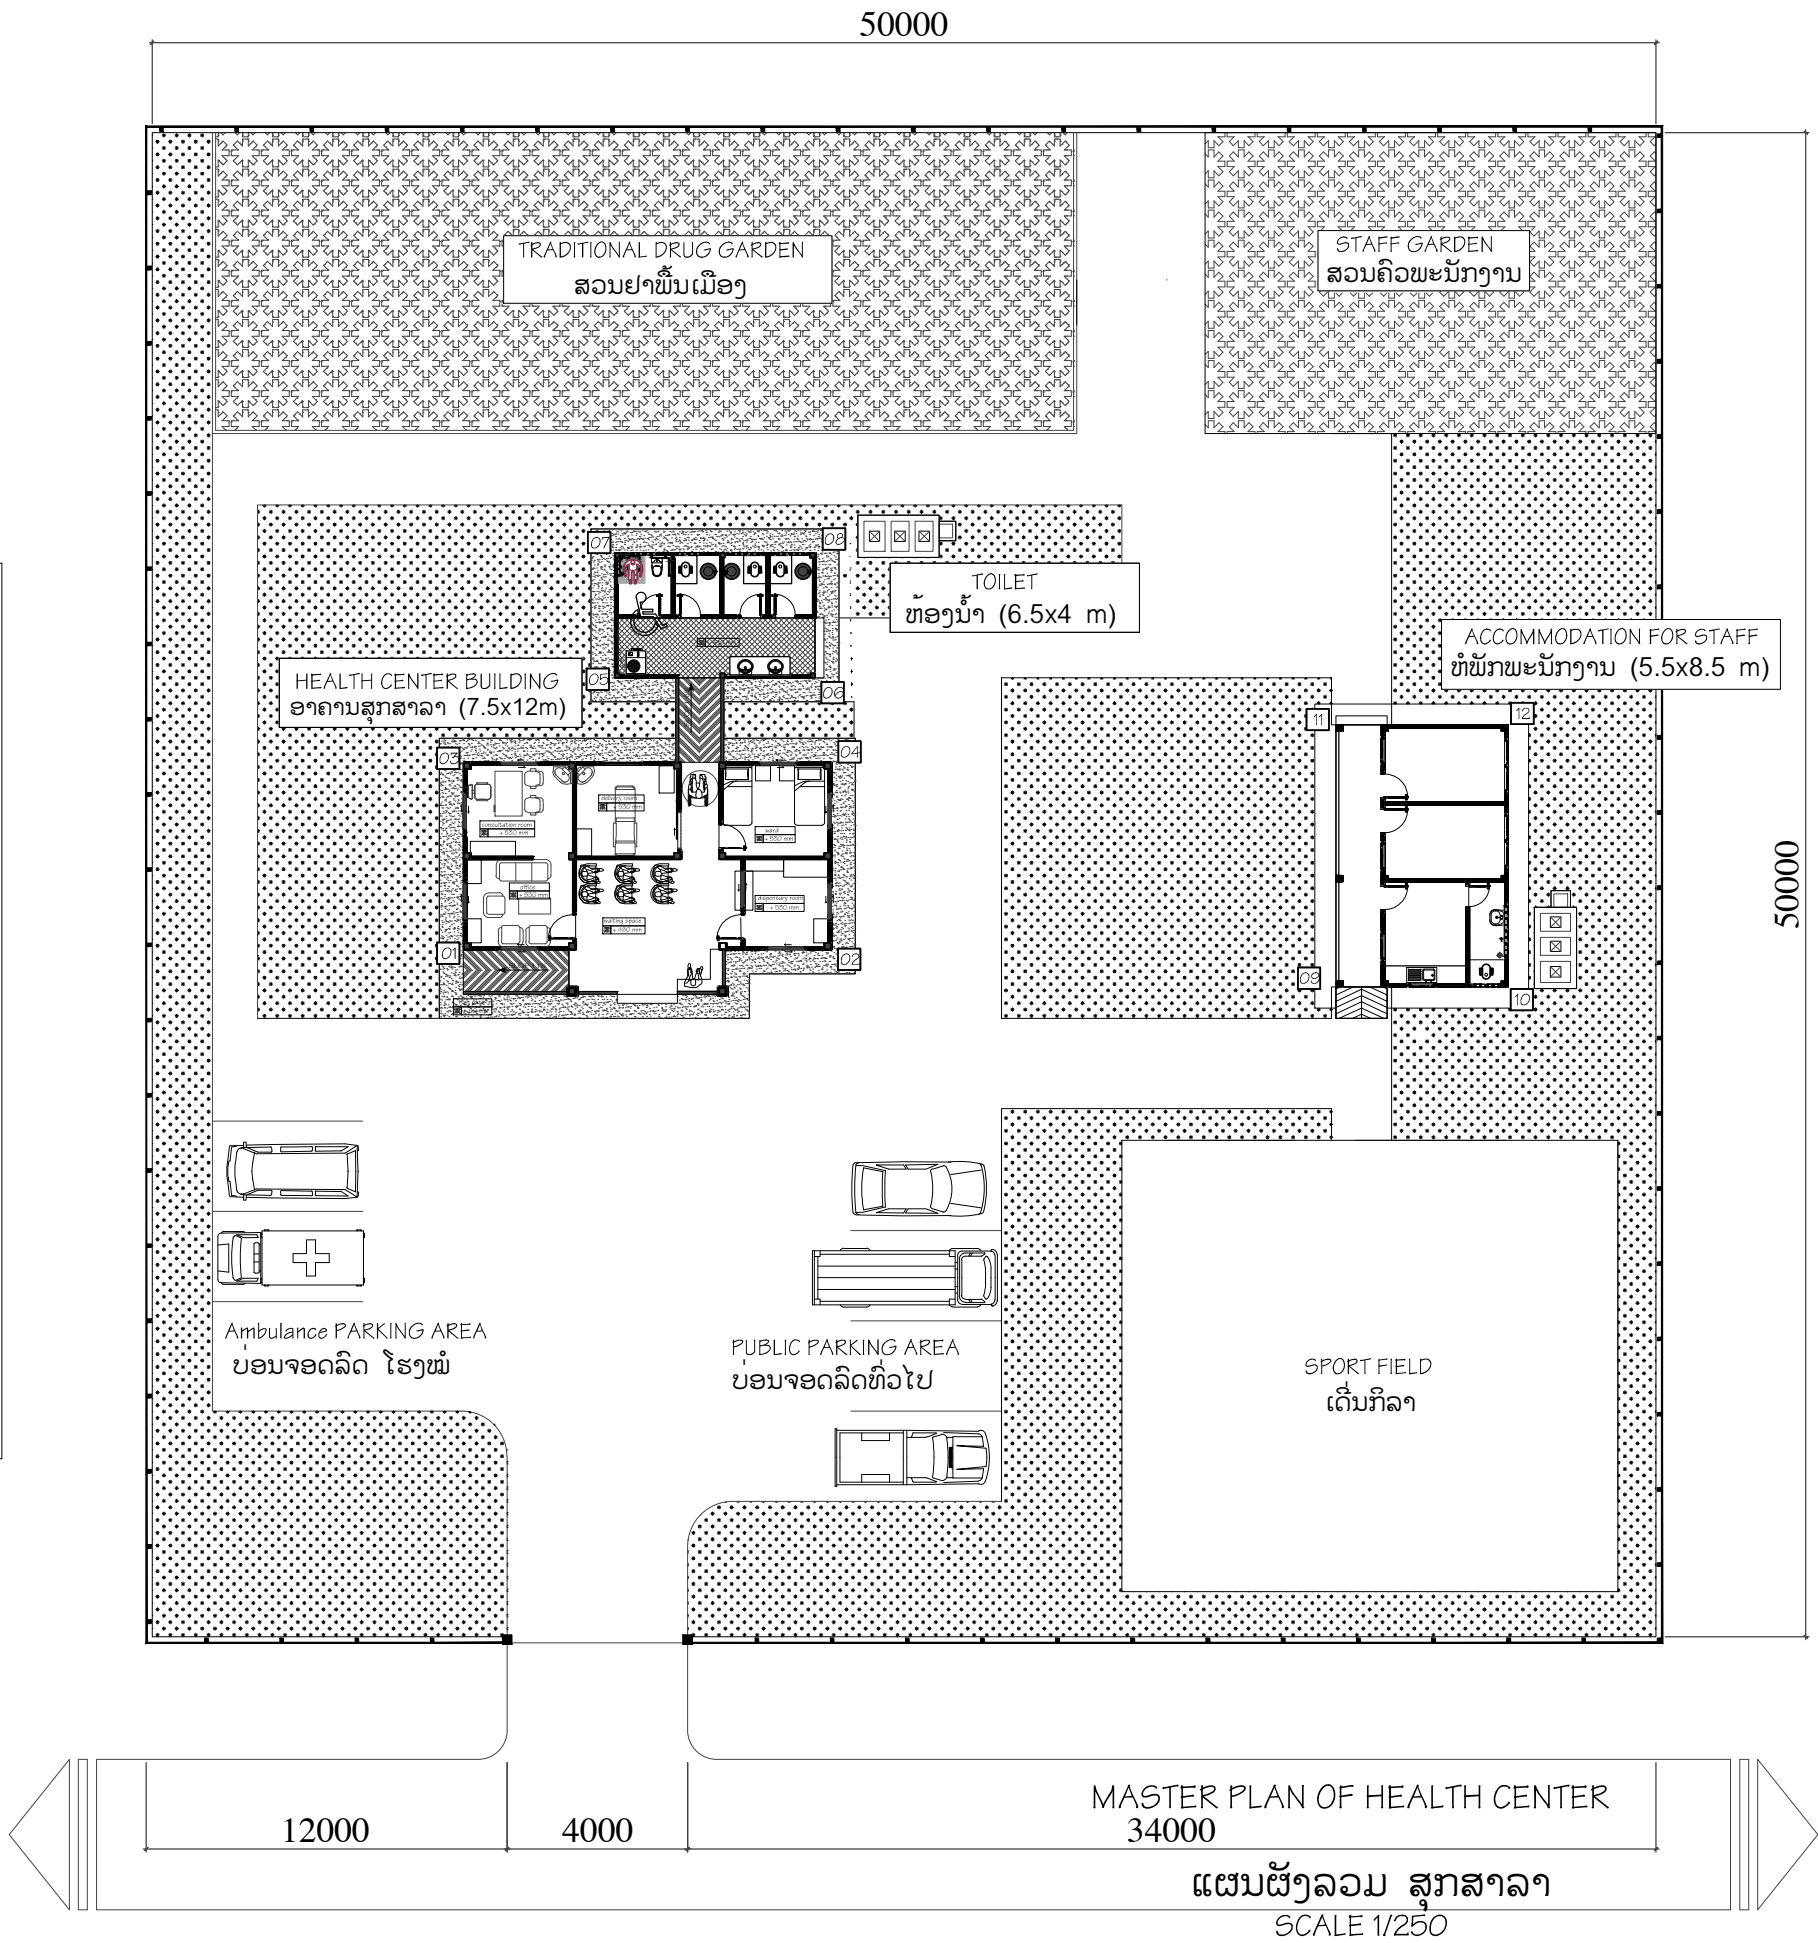

NAM NGIEP 1
POWER COMPANY

DEPARTMENT		
ENVIRONMENT AND SOCIAL DIVISION		
PROJECT		
NAM NGIEP1 HYDROPOWER PROJECT		
PROJECT ACTIVITIES		
Community Building Construction		
BUILDING NAME		
Health Center with Toilet (Main building)		
DRAWING NAME		
Master Plan		
REV.NO.	JOB DESCRIPTION	
1		
2		
3		
ARCHITECT		
1	Vylar KEBOUNMY	
2	Chengvang TONGTOUA	
ENGINEERING		
1	Pinthong SOPHATHILATH	
2	Chome PHOMMACHANH	
3		
DRAWN		
1	Vylar KEBOUNMY	
2	Chengvang TONGTOUA	
3		
CHECKED		
1	Gerlee CHANORYIA	
2	Chome PHOMMACHANH	
VERIFIED		
1	KENICHI Tomioka	
2		
APPROVED		
1		
2		
PRINTED DATE		
30/11/2015		
SCALE:	DWG NO.	
1/250	Page 03/HC-MP.02	



**NAM NGIEP 1
POWER COMPANY**

DEPARTMENT
ENVIRONMENT
AND SOCIAL DIVISION

PROJECT
NAM NGIEP1
HYDROPOWER PROJECT

PROJECT ACTIVITIES
Community Building Construction

BUILDING NAME
Health Center with Toilet
(Main building)

DRAWING NAME
FLOOR PLAN

REV.NO.	JOB DESCRIPTION
1	
2	
3	

ARCHITECT

1	Vylar KEOUNMY	
2	Chengvang TONGTOUA	

ENGINEERING

1	Pinthong SOPHATHILATH	
2	Chome PHOMMACHANH	
3		

DRAWN

1	Vylar KEOUNMY	
2	Chengvang TONGTOUA	
3		

CHECKED

1	Gerlee CHANORYIA	
2	Chome PHOMMACHANH	

VERIFIED


1	KENICHI Tomioka	
2		

APPROVED

1		
2		

PRINTED DATE
30/11/2015

SCALE: 1/150
DWG NO. Page 04/HC-AR.01

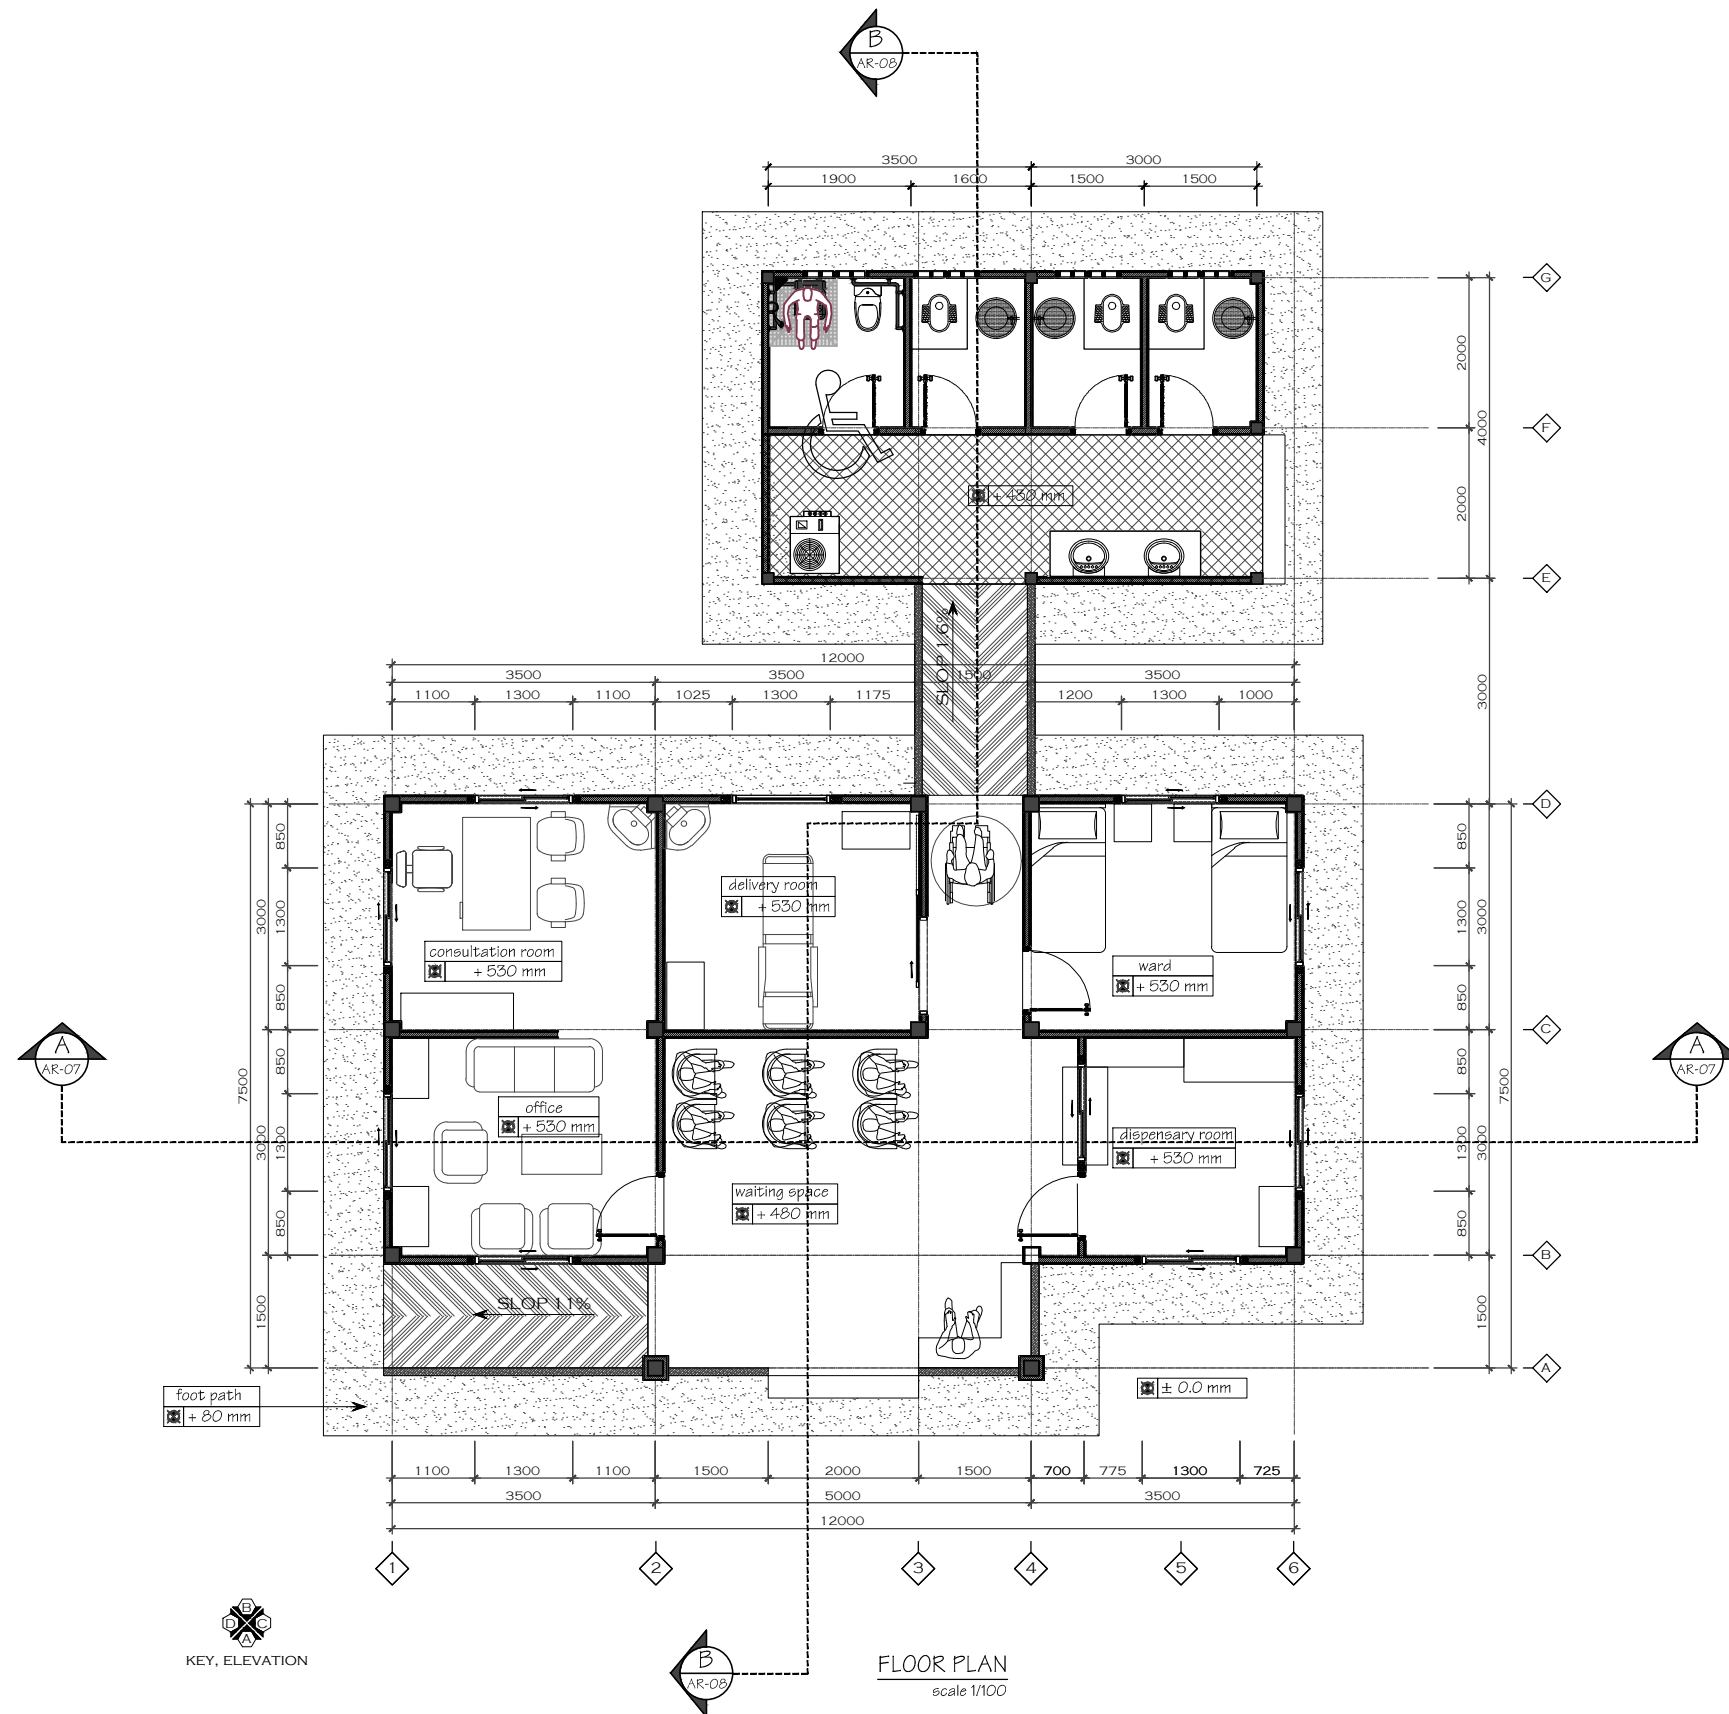



NAM NGIEP 1
POWER COMPANY

DEPARTMENT
ENVIRONMENT
AND SOCIAL DIVISION

PROJECT
NAM NGIEP1
HYDROPOWER PROJECT

PROJECT ACTIVITIES
Community Building Construction

BUILDING NAME
Health Center with Toilet
(Main building)

DRAWING NAME
ROOF PLAN

REV.NO.	JOB DESCRIPTION
1	
2	
3	

ARCHITECT		
1	Vylar KEOBOUNMY	
2	Chengvang TONGTOUA	

ENGINEERING		
1	Pinthong SOPHATHILATH	
2	Chome PHOMMACHANH	
3		

DRAWN		
1	Vylar KEOBOUNMY	
2	Chengvang TONGTOUA	
3		


CHECKED		
1	Gerlee CHANORYIA	
2	Chome PHOMMACHANH	

VERIFIED		
1	KENICHI Tomioka	
2		

APPROVED		
1		
2		

PRINTED DATE
30/11/2015

SCALE: 1/150
DWG NO. Page 05/HC-AR.02

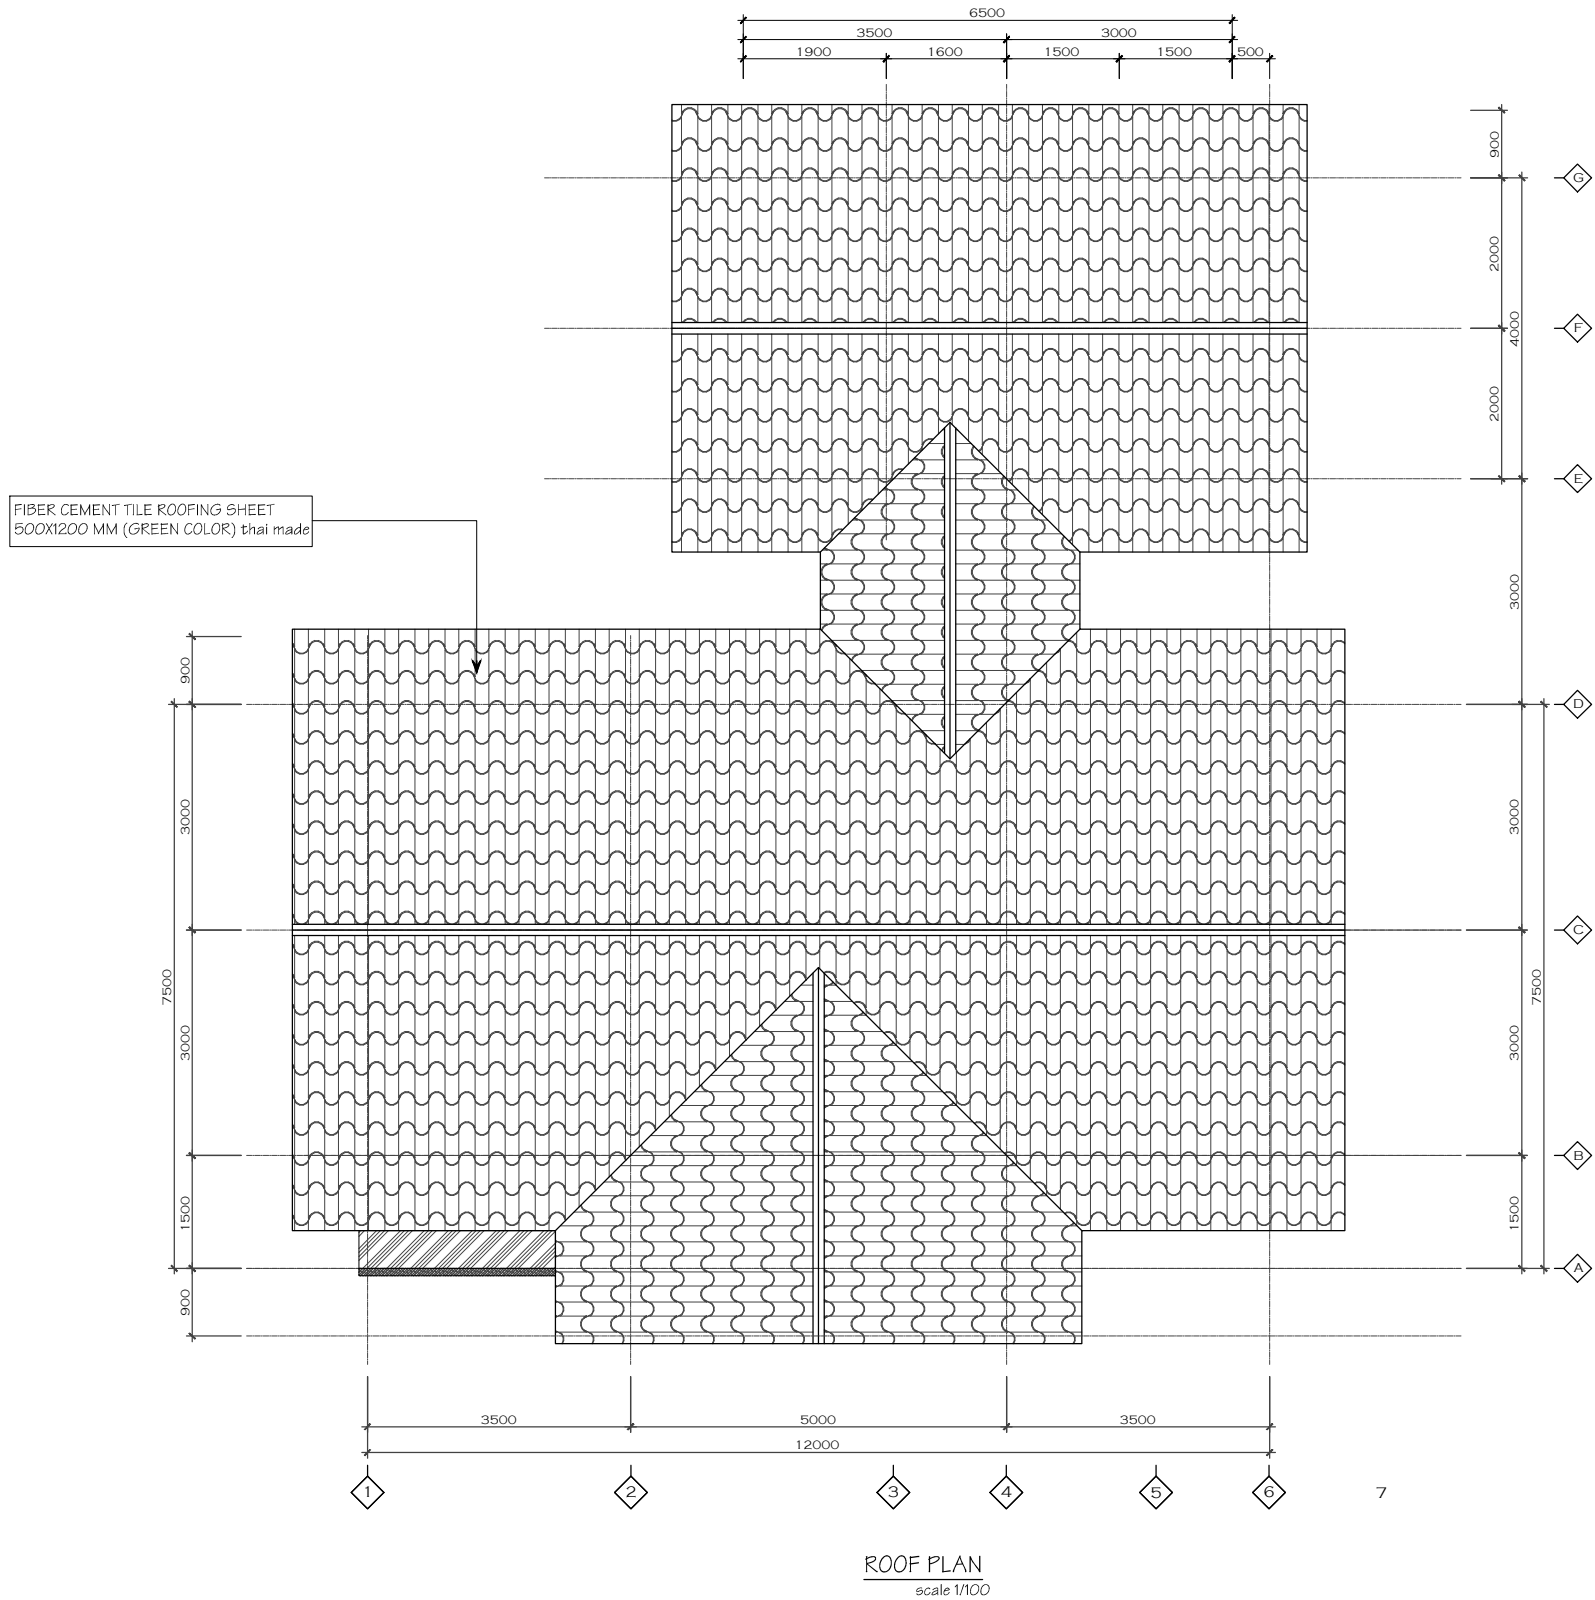



NAM NGIEP 1
POWER COMPANY

DEPARTMENT
ENVIRONMENT
AND SOCIAL DIVISION

PROJECT
NAM NGIEP1
HYDROPOWER PROJECT

PROJECT ACTIVITIES
Community Building Construction

BUILDING NAME
Health Center with Toilet
(Main building)

DRAWING NAME
ELEVATION A

REV.NO.	JOB DESCRIPTION
1	
2	
3	

ARCHITECT		
1	Vylar KEOUNMY	
2	Chengvang TONGTOUA	

ENGINEERING		
1	Pinthong SOPHATHILATH	
2	Chome PHOMMACHANH	
3		

DRAWN		
1	Vylar KEOUNMY	
2	Chengvang TONGTOUA	
3		


CHECKED		
1	Gerlee CHANORYIA	
2	Chome PHOMMACHANH	

VERIFIED		
1	KENICHI Tomioka	
2		

APPROVED		
1		
2		

PRINTED DATE
30/11/2015

SCALE:	DWG NO.
1/75	Page 06/HC-AR.03

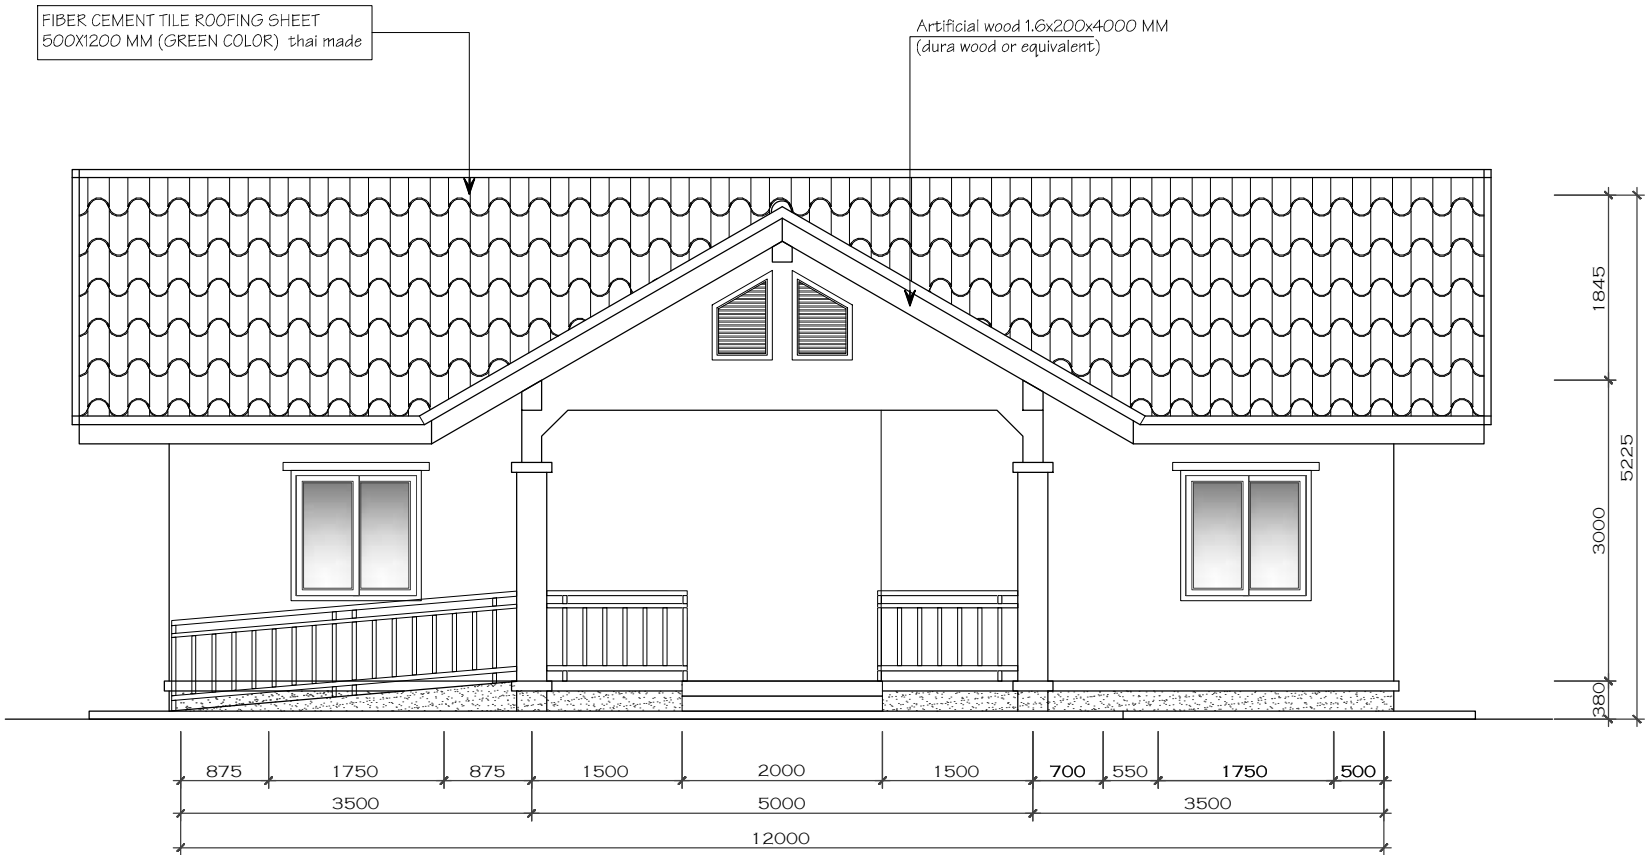

ELEVATION A
scale 1/75



NAM NGIEP 1
POWER COMPANY

DEPARTMENT
ENVIRONMENT
AND SOCIAL DIVISION

PROJECT
NAM NGIEP1
HYDROPOWER PROJECT

PROJECT ACTIVITIES
Community Building Construction

BUILDING NAME
Health Center with Toilet
(Main building)

DRAWING NAME
ELEVATION B

REV.NO.	JOB DESCRIPTION
1	
2	
3	

ARCHITECT		
1	Vylar KEOBOUNMY	
2	Chengvang TONGTOUA	

ENGINEERING		
1	Pinthong SOPHATHILATH	
2	Chome PHOMMACHANH	
3		

DRAWN		
1	Vylar KEOBOUNMY	
2	Chengvang TONGTOUA	
3		


CHECKED		
1	Gerlee CHANORYIA	
2	Chome PHOMMACHANH	

VERIFIED		
1	KENICHI Tomioka	
2		

APPROVED		
1		
2		

PRINTED DATE
30/11/2015

SCALE: 1/75
DWG NO. Page 07/HC-AR.04

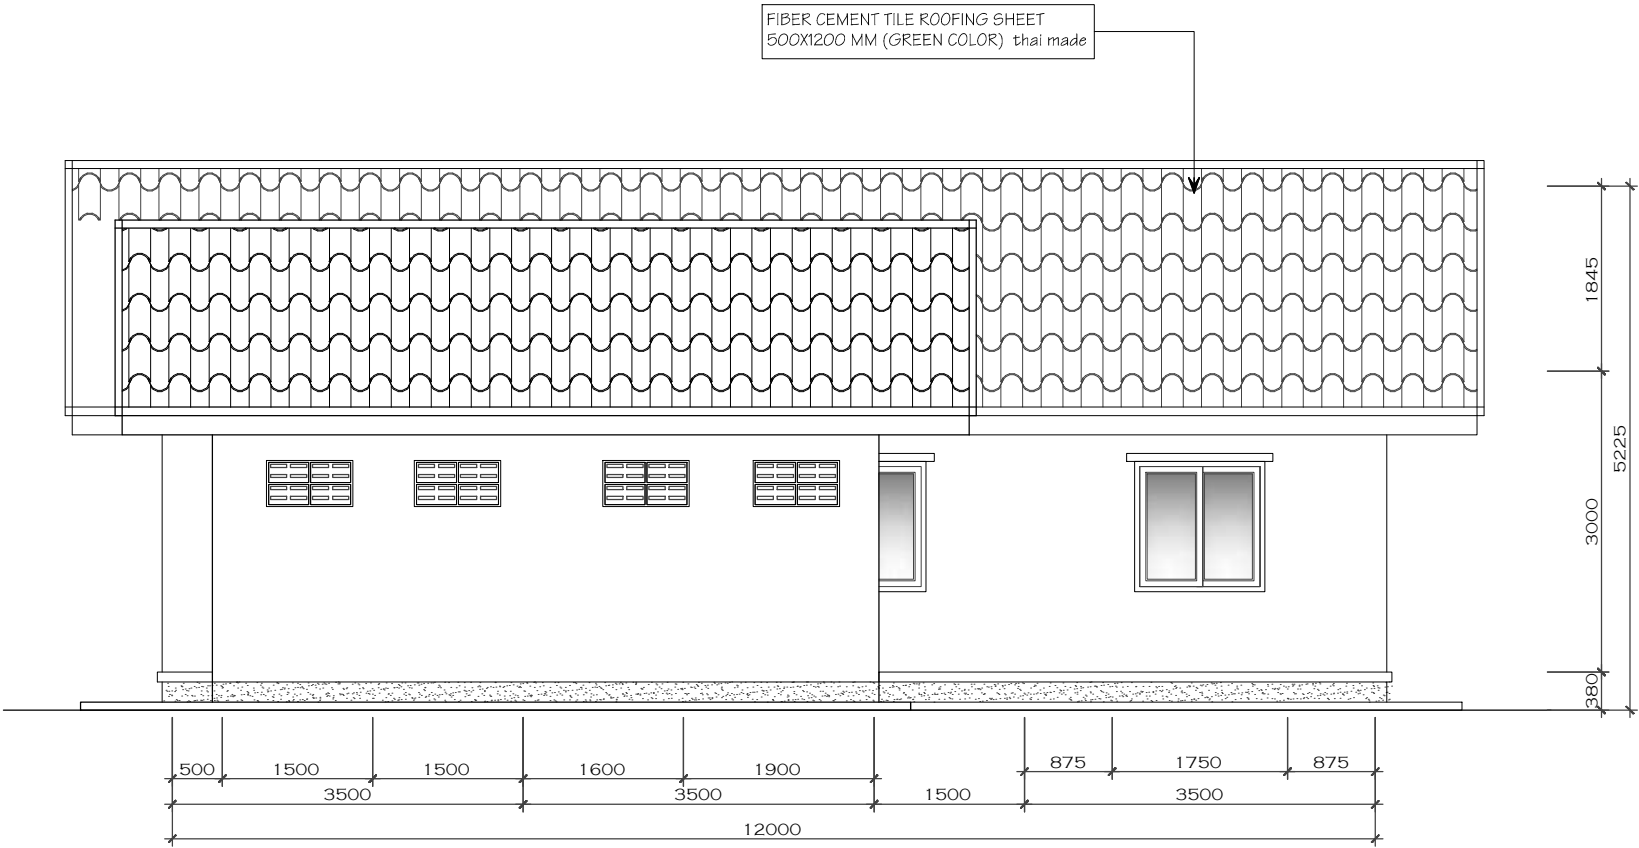

ELEVATION B
scale 1/40



NAM NGIEP 1
POWER COMPANY

DEPARTMENT
ENVIRONMENT
AND SOCIAL DIVISION

PROJECT
NAM NGIEP1
HYDROPOWER PROJECT

PROJECT ACTIVITIES
Community Building Construction

BUILDING NAME
Health Center with Toilet
(Main building)

DRAWING NAME
ELEVATION C

REV.NO.	JOB DESCRIPTION
1	
2	
3	

ARCHITECT		
1	Vylar KEOUNMY	
2	Chengvang TONGTOUA	

ENGINEERING		
1	Pinthong SOPHATHILATH	
2	Chome PHOMMACHANH	
3		

DRAWN		
1	Vylar KEOUNMY	
2	Chengvang TONGTOUA	
3		


CHECKED		
1	Gerlee CHANORYIA	
2	Chome PHOMMACHANH	

VERIFIED		
1	KENICHI Tomioka	
2		

APPROVED		
1		
2		

PRINTED DATE
30/11/2015

SCALE: 1/75
DWG NO. Page 08/HC-AR.05

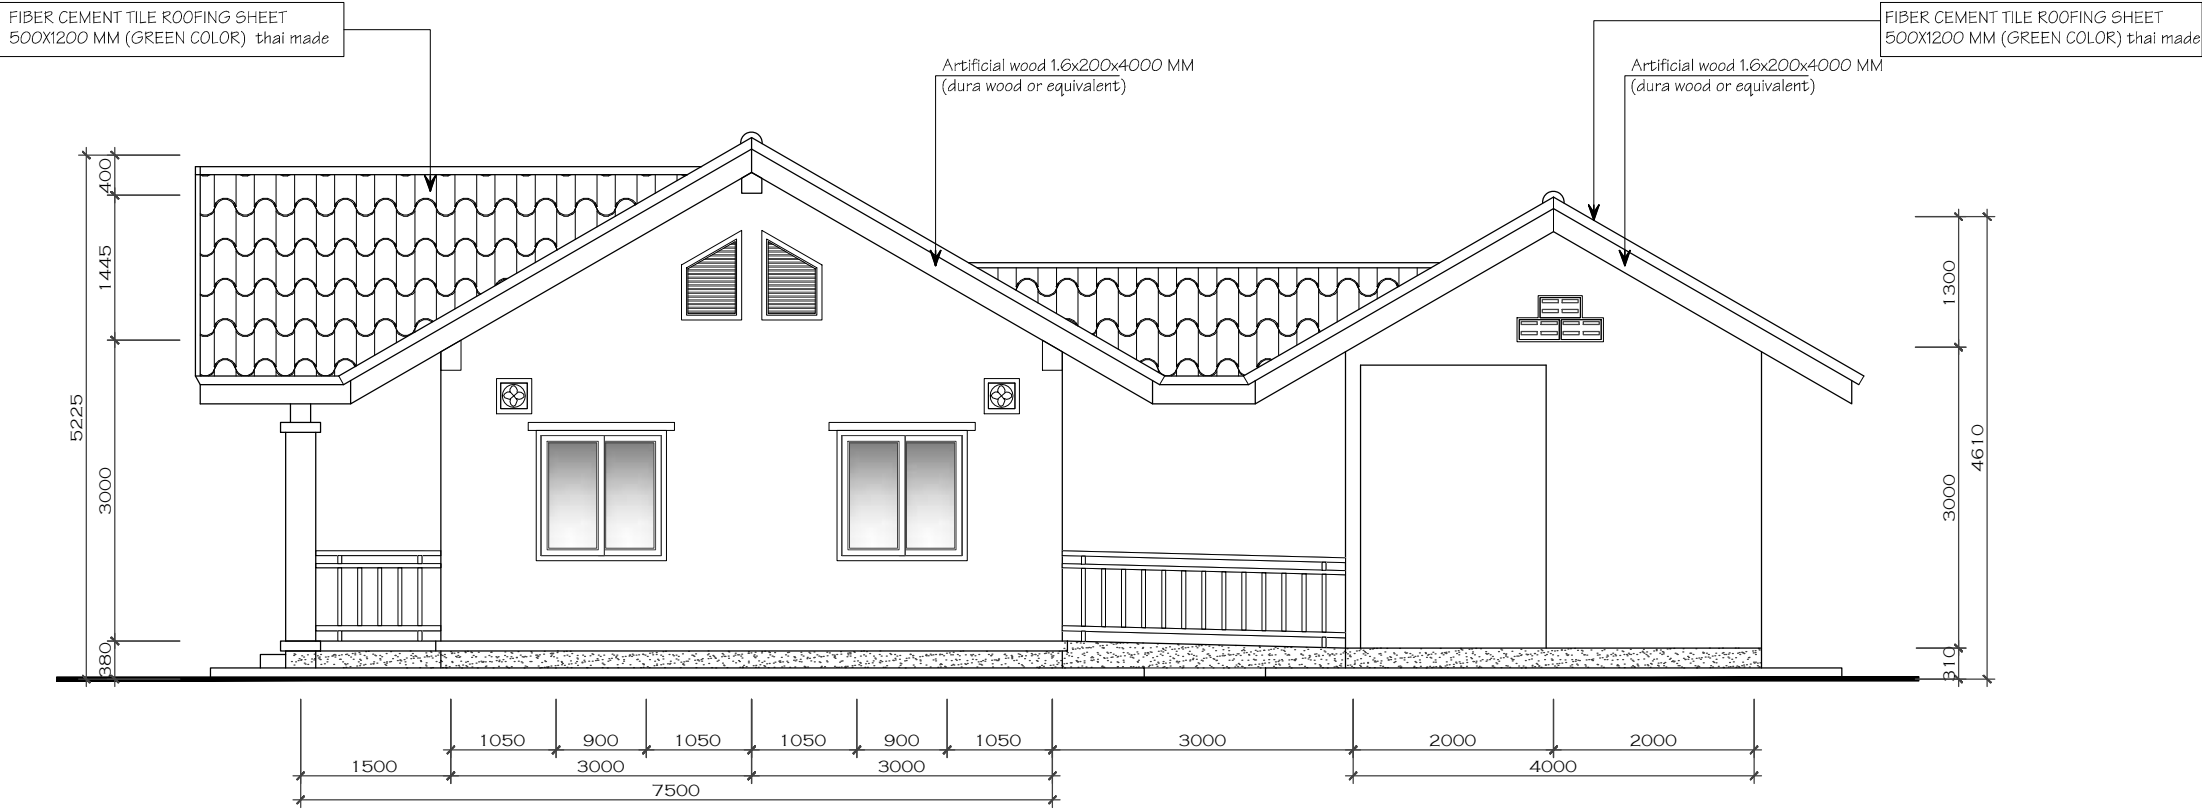

ELEVATION C
scale 1/40



NAM NGIEP 1
POWER COMPANY

DEPARTMENT
ENVIRONMENT
AND SOCIAL DIVISION

PROJECT
NAM NGIEP1
HYDROPOWER PROJECT

PROJECT ACTIVITIES
Community Building Construction

BUILDING NAME
Health Center with Toilet
(Main building)

DRAWING NAME
ELEVATION D

REV.NO.	JOB DESCRIPTION
1	
2	
3	

ARCHITECT

1	Vylar KEOUNMY	
2	Chengvang TONGTOUA	

ENGINEERING

1	Pinthong SOPHATHILATH	
2	Chome PHOMMACHANH	
3		

DRAWN

1	Vylar KEOUNMY	
2	Chengvang TONGTOUA	
3		

CHECKED

1	Gerlee CHANORYIA	
2	Chome PHOMMACHANH	

VERIFIED


1	KENICHI Tomioka	
2		

APPROVED

1		
2		

PRINTED DATE
30/11/2015

SCALE: 1/75
DWG NO. Page 09/HC-AR.06

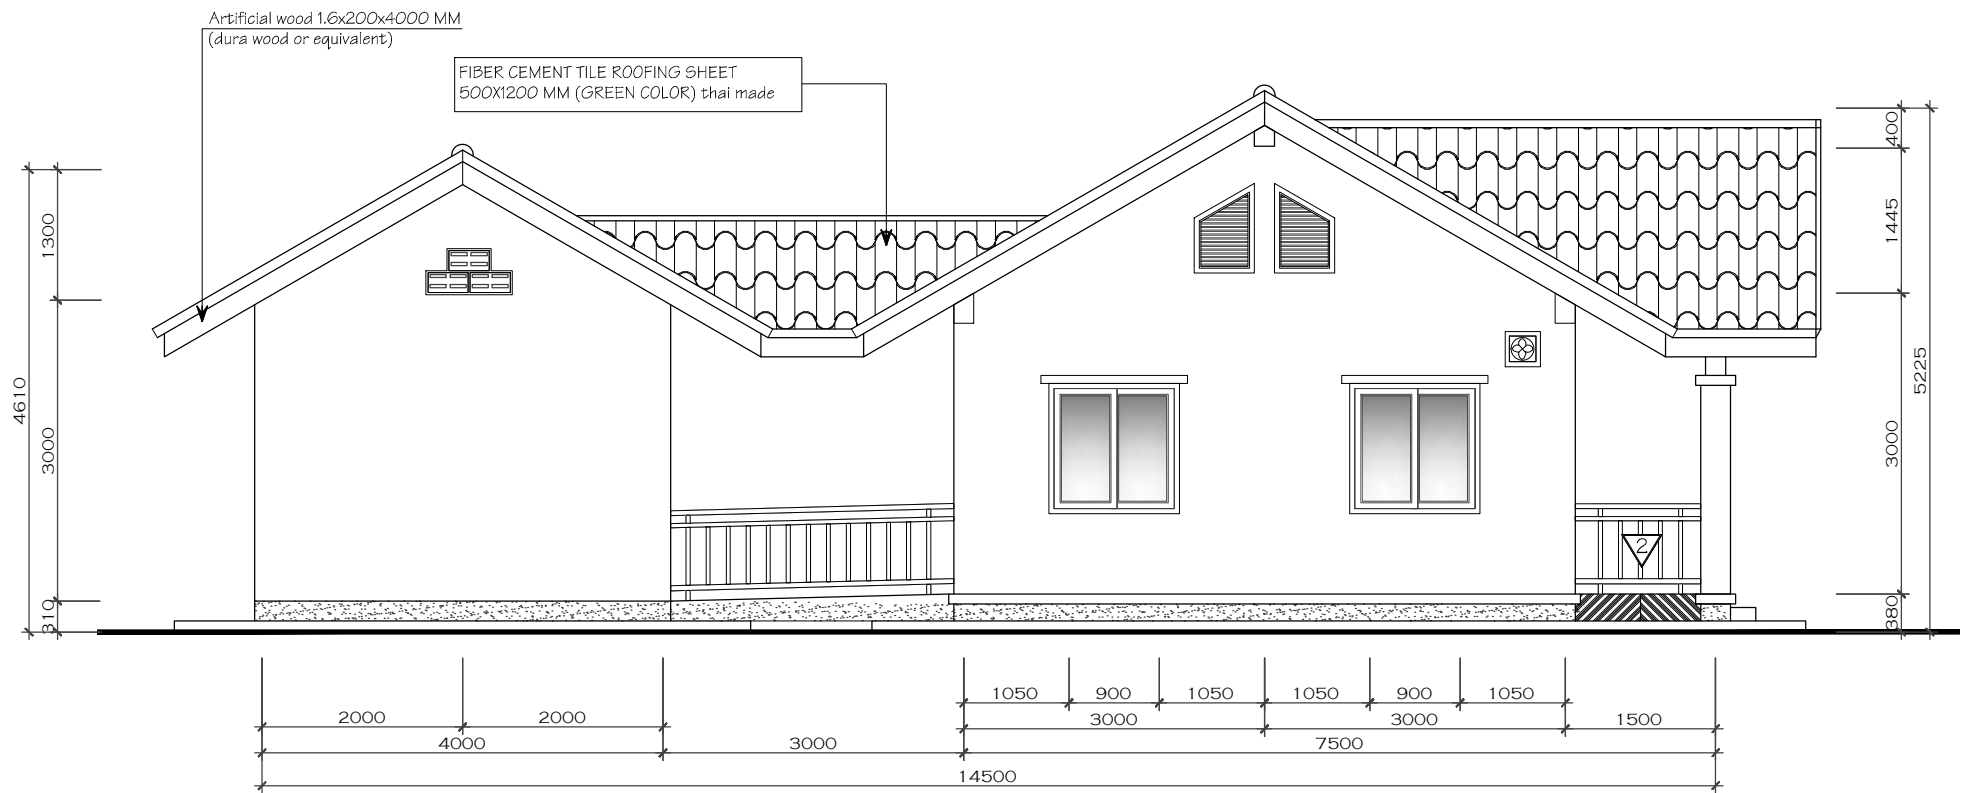

ELEVATION D
scale 1/40



NAM NGIEP 1
POWER COMPANY

DEPARTMENT
ENVIRONMENT
AND SOCIAL DIVISION

PROJECT
NAM NGIEP1
HYDROPOWER PROJECT

PROJECT ACTIVITIES
Community Building Construction

BUILDING NAME
Health Center with Toilet
(Main building)

DRAWING NAME
SECTION A-A

REV.NO.	JOB DESCRIPTION
1	
2	
3	

ARCHITECT		
1	Vylar KEOUNMY	
2	Chengvang TONGTOUA	

ENGINEERING		
1	Pinthong SOPHATHILATH	
2	Chome PHOMMACHANH	
3		

DRAWN		
1	Vylar KEOUNMY	
2	Chengvang TONGTOUA	
3		


CHECKED		
1	Gerlee CHANORYIA	
2	Chome PHOMMACHANH	

VERIFIED		
1	KENICHI Tomioka	
2		

APPROVED		
1		
2		

PRINTED DATE
30/11/2015

SCALE: 1/75
DWG NO. Page 10/HC-AR.07

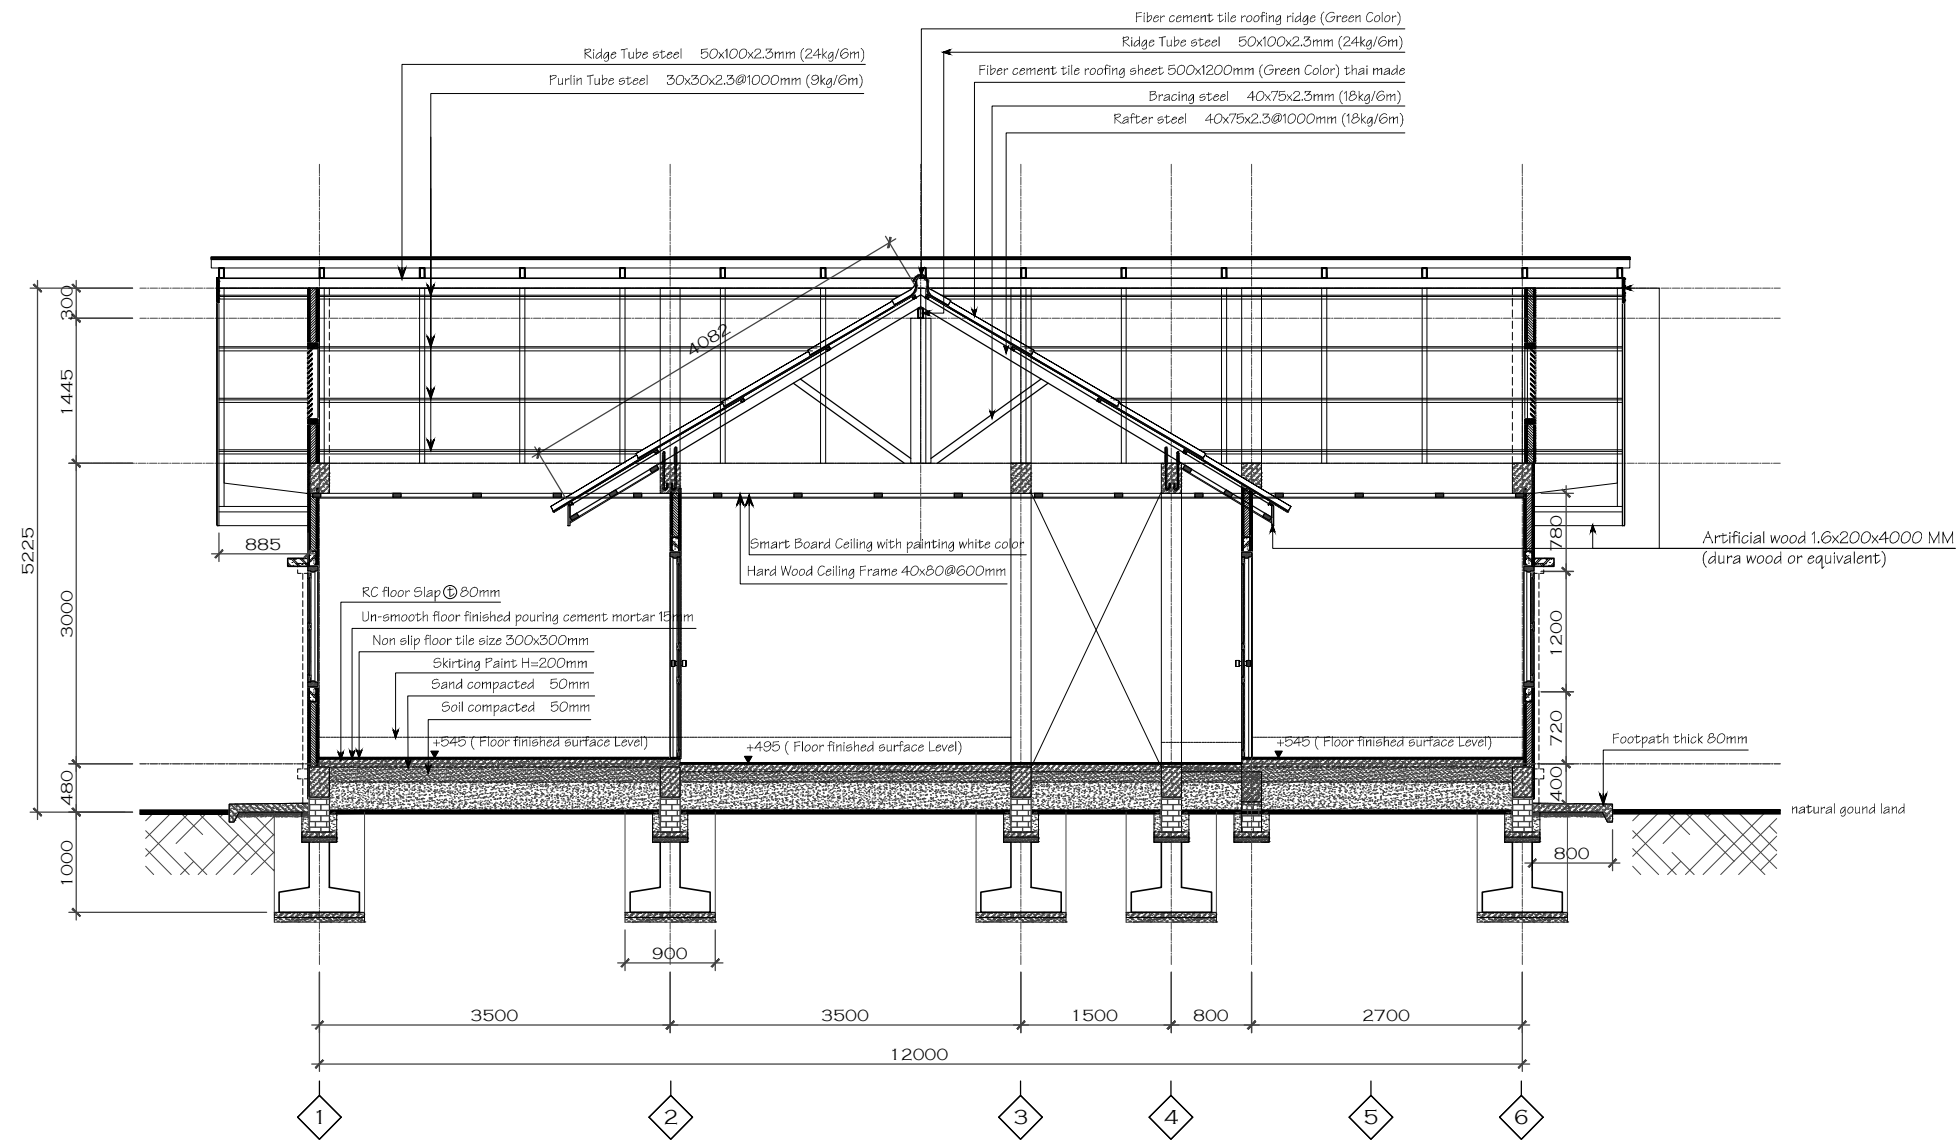

SECTION A-A
scale 1/40



**NAM NGIEP 1
POWER COMPANY**

DEPARTMENT

**ENVIRONMENT
AND SOCIAL DIVISION**

PROJECT

**NAM NGIEP1
HYDROPOWER PROJECT**

PROJECT ACTIVITIES

Community Building Construction

BUILDING NAME

**Health Center with Toilet
(Main building)**

DRAWING NAME

SECTION B-B

REV.NO.	JOB DESCRIPTION
---------	-----------------

1	
2	
3	

ARCHITECT

1	Vylar KEOUNMY	
2	Chengvang TONGTOUA	

ENGINEERING

1	Pinthong SOPHATHILATH	
2	Chome PHOMMACHANH	
3		

DRAWN

1	Vylar KEOUNMY	
2	Chengvang TONGTOUA	
3		

CHECKED

1	Gerlee CHANORYIA	
2	Chome PHOMMACHANH	

VERIFIED

1	KENICHI Tomioka	
2		

APPROVED

1		
2		

PRINTED DATE


30/11/2015

SCALE:

DWG NO.

1/75

Page 11/HC-AR.08

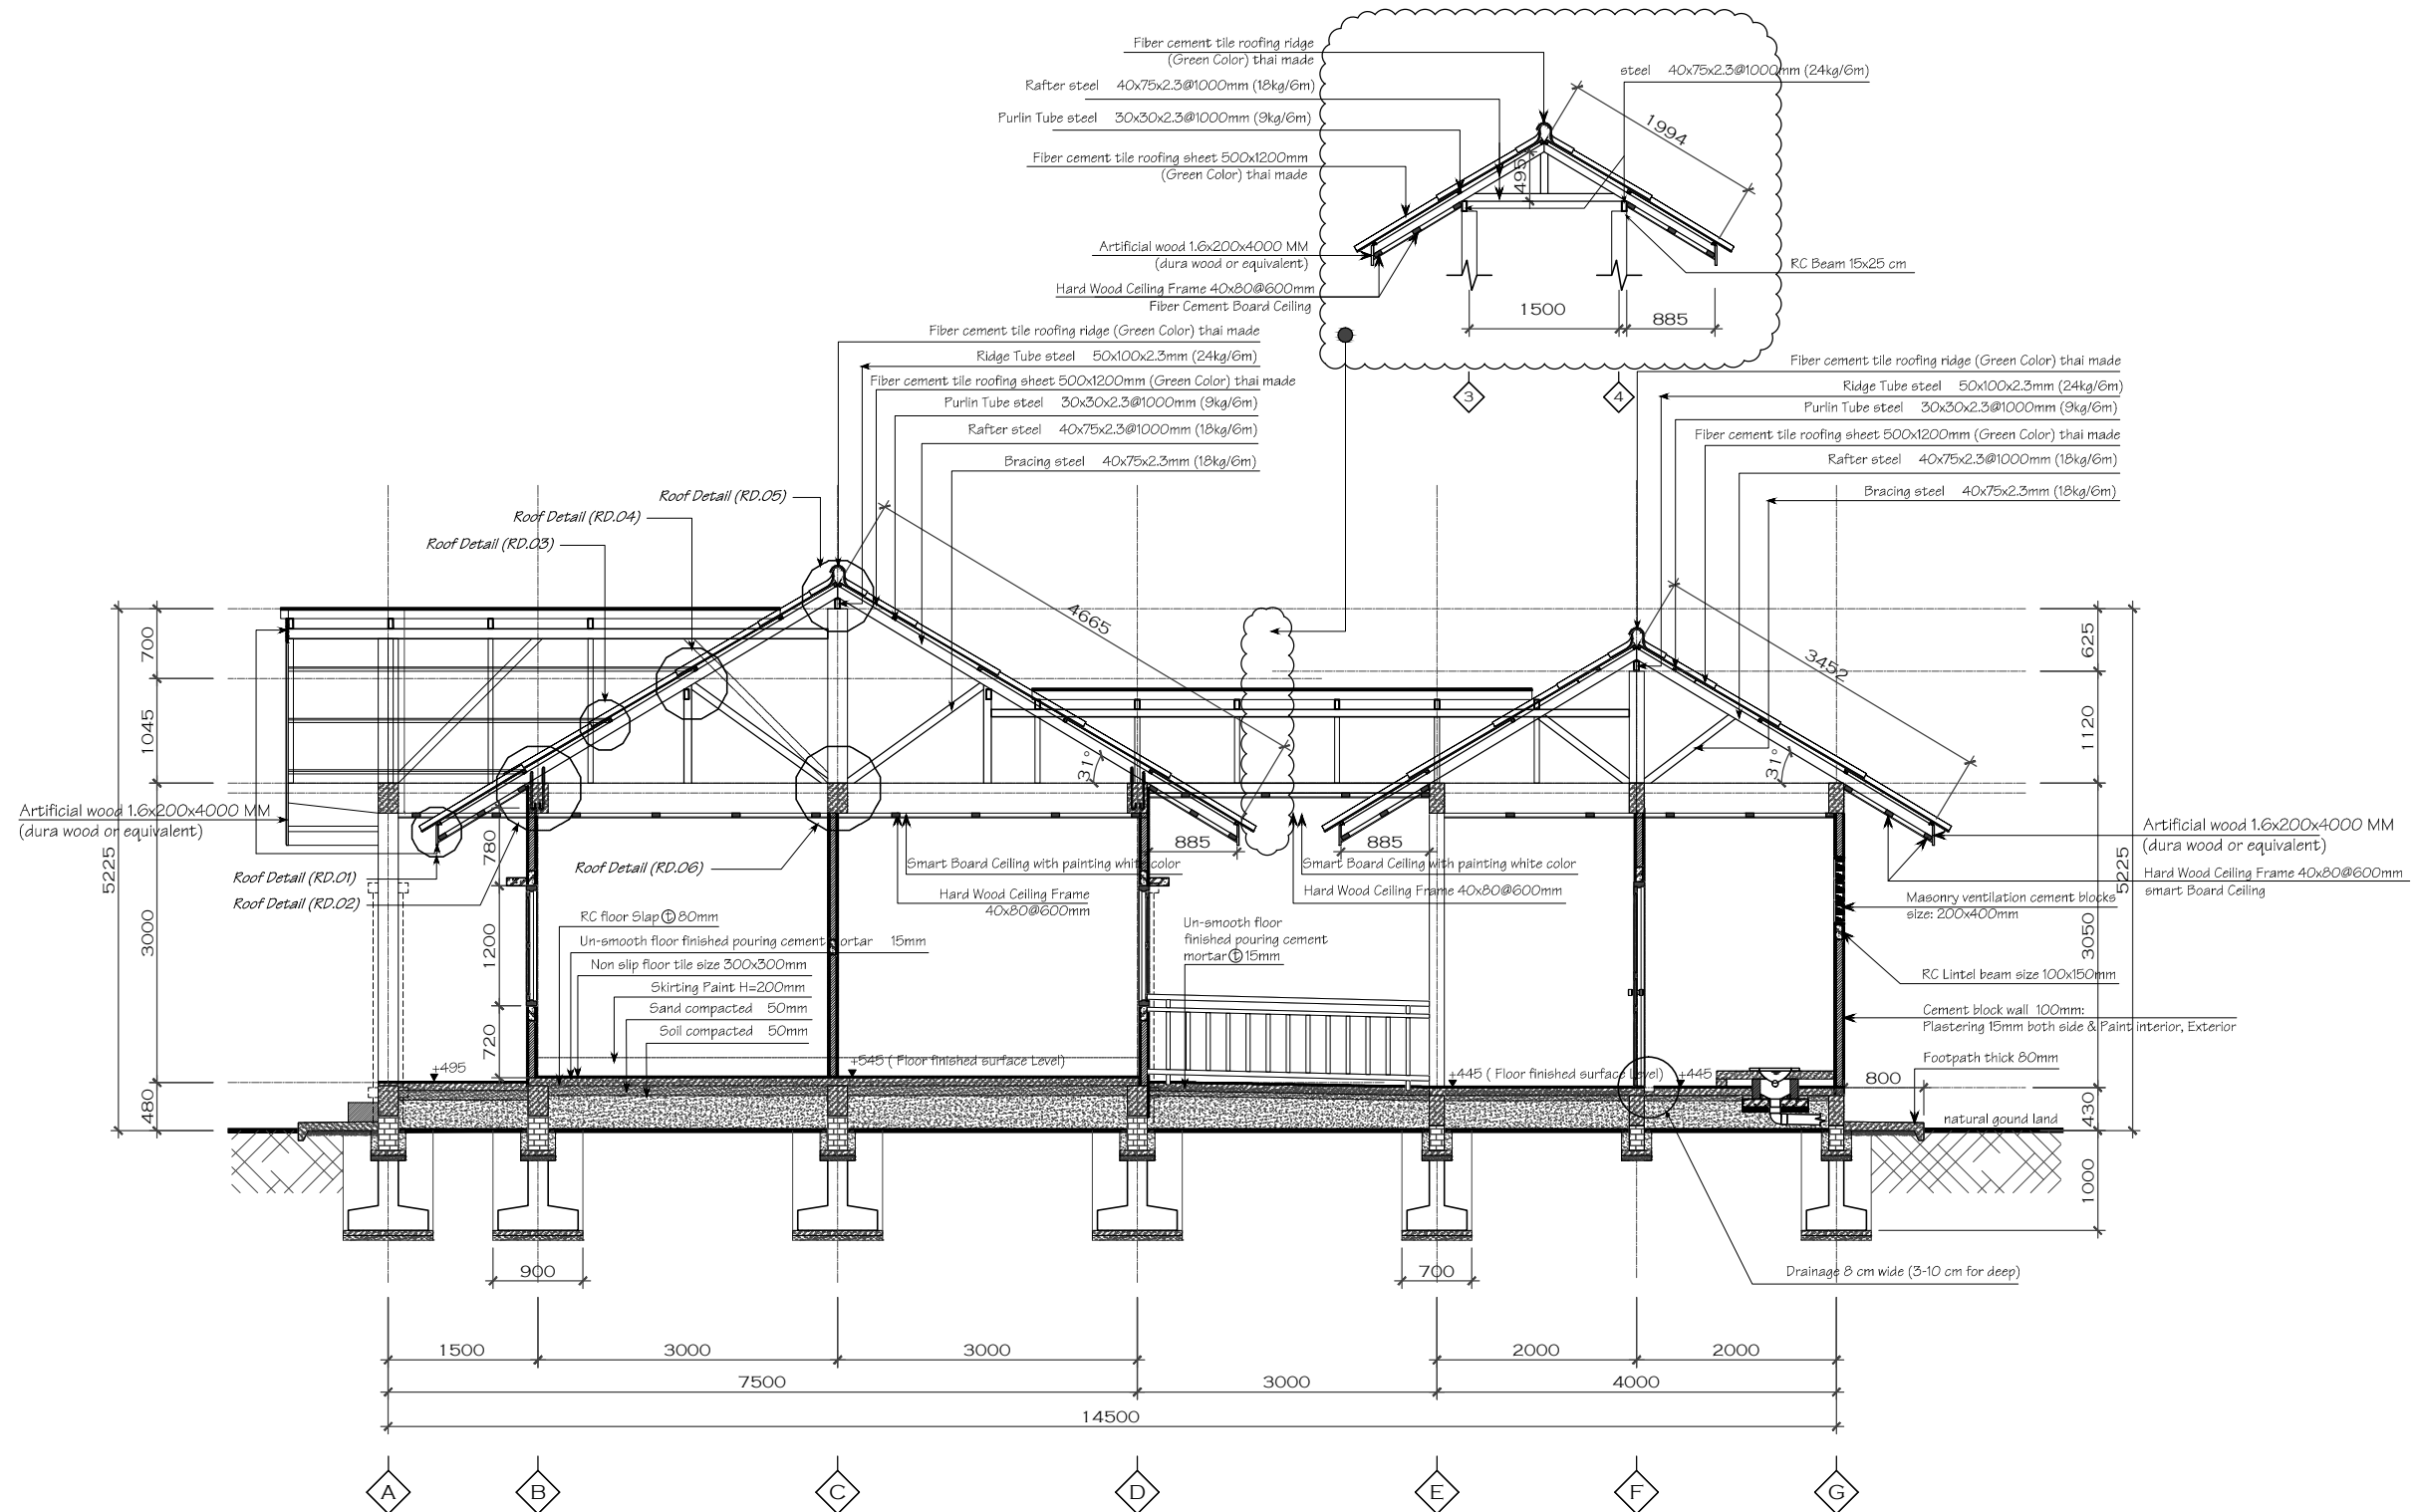

SECTION B-B
scale 1/40